






1 PERSPECTIVE
A-1 SCALE NTS

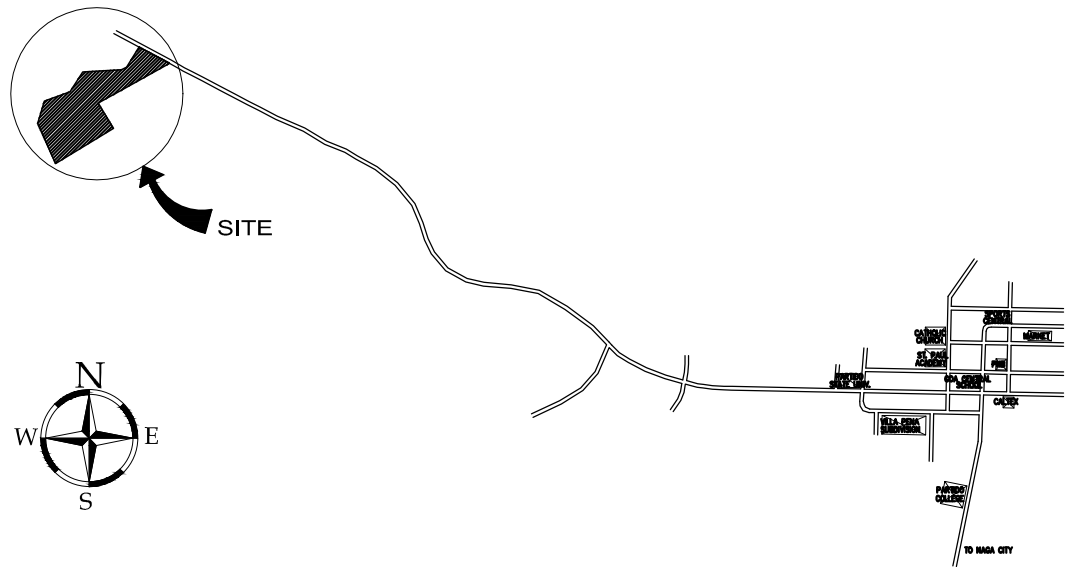

2 VICINITY MAP
A-1 SCALE NTS

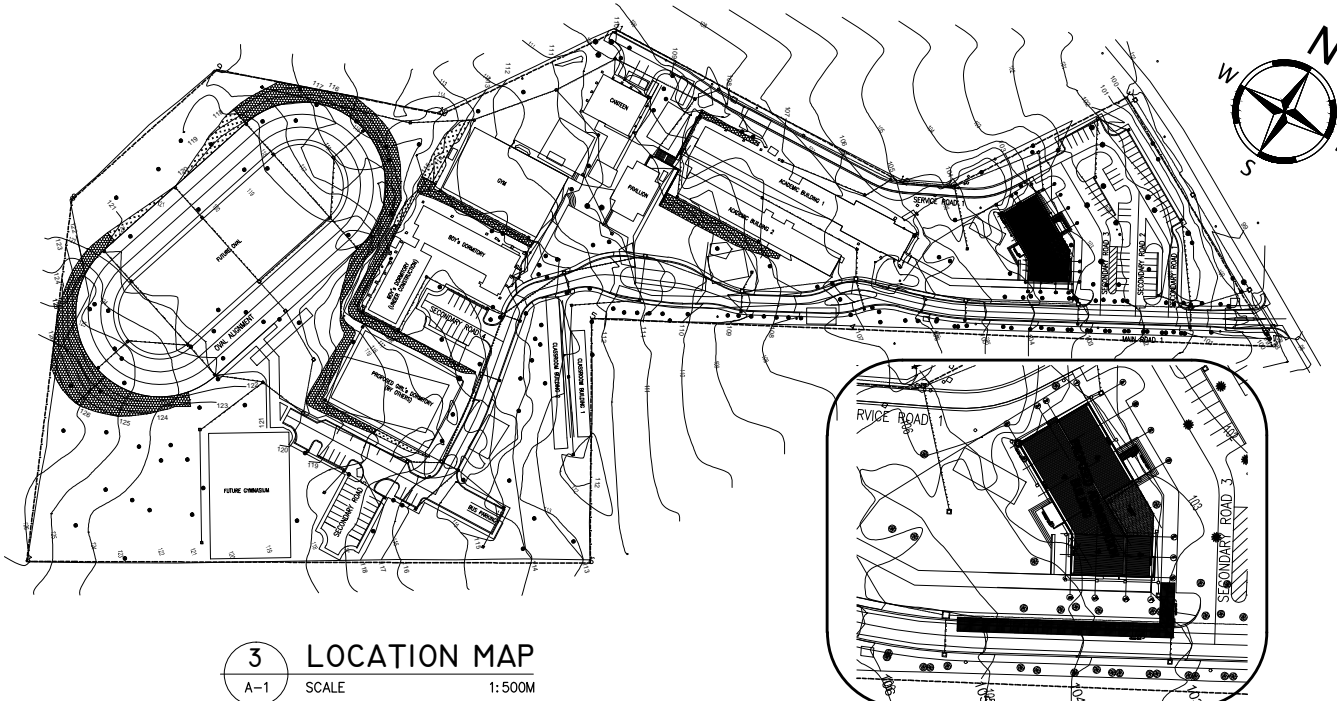

3 LOCATION MAP
A-1 SCALE 1:500M

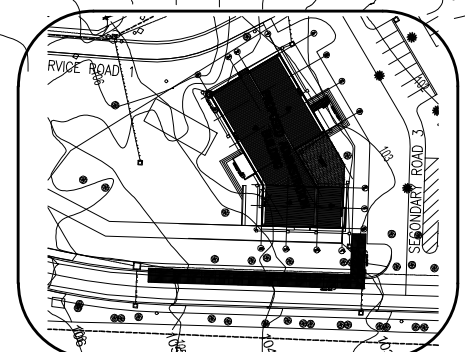

4 SITE DEVELOPMENT PLAN
A-1 SCALE 1:750M

TABLE OF CONTENTS

ARCHITECTURAL		ELECTRICAL	
A-1	TABLE OF CONTENTS	E-1	GENERAL NOTES, LEGEND & SYMBOLS
	LOCATION PLAN, VICINITY MAP	E-2	GROUND FLOOR LIGHTING LAYOUT
	SITE DEVELOPMENT PLAN		SECOND FLOOR LIGHTING LAYOUT
A-2	GROUND FLOOR PLAN	E-3	GROUND FLOOR POWER, TEL., & DATA LAYOUT
A-3	SECOND FLOOR PLAN		SECOND FLOOR POWER, TEL., & DATA LAYOUT
A-4	GROUND FLOOR PATTERN LAYOUT	E-4	GROUND FIRE ALARM LAYOUT
A-5	SECOND FLOOR PATTERN LAYOUT		SECOND FIRE ALARM LAYOUT
A-6	GROUND FLOOR WALL FINISH LAYOUT	E-5	LOAD SCHEDULE, TELEPHONE RISER DIAGRAM
A-7	SECOND FLOOR WALL FINISH LAYOUT		DATA RISER DIAGRAM, LIGHTING FIXTURE SCHEDULE, MOUNTING DETAILS
A-8	GROUND FLOOR REFLECTED CEILING PLAN		
A-9	SECOND FLOOR REFLECTED CEILING PLAN		
A-10	ROOF PLAN		
A-11	ELEVATIONS & SECTIONS		
A-11.1	DETAIL OF TOILET 1, 2, & PANTRY	M-1	GENERAL NOTES, LEGEND, SYMBOLS & ABBREVIATIONS
A-11.2	DETAIL OF TOILET 3, 4, & PANTRY		EQUIPMENT SCHEDULE
A-11.3	DETAIL OF TOILET 5, 6, 7, & PANTRY	M-2	GROUND FLOOR A/C VENTILATION LAYOUT
	DETAIL OF LOGO W/ ACCENT	M-3	SECOND FLOOR A/C VENTILATION LAYOUT
A-11.4	DETAIL OF SUSPENDED CANOPY		
	DETAIL OF LOGO/GSIGNIA	M-4	MISCELLANEOUS DETAILS
A-11.5	DETAIL OF RAMP-UP		
	DETAIL OF RAILING @ VERANDA		
	DETAIL OF LADDERRIZE F.E		
A-12	SCHEDULE OF DOORS	P-1	GENERAL NOTES, LEGEND & SYMBOLS
	SCHEDULE OF WINDOWS		MATERIAL SPECIFICATIONS & MISCELLANEOUS DETAILS
	COVERED WALK DETAIL	P-2	GROUND FLOOR DRAINAGE, SEWER/ VENT LAYOUT
A-13	DETAILED SECTION:	P-3	SECOND FLOOR DRAINAGE, SEWER/ VENT LAYOUT
	COUNTERTOP & OVERHEAD CABINET		
	KITCHEN SINK, CONNECTION DETAIL	P-4	ROOF DRAINAGE LAYOUT
		P-5	GROUND FLOOR WATERLINE LAYOUT
S-1	GENERAL NOTES	P-6	SECOND FLOOR WATERLINE LAYOUT
S-2	ATANDARD DETAILS	P-7	SANITARY ISOMETRIC LAYOUT
S-3	FOUNDATION PLAN, TYPICAL FOOTING DETAIL, WALL FOOTING DETAIL		
S-4	SECOND FLOOR FRAMING PLAN		
	SCHEDULE OF COLUMN, TYPICAL COLUMN ELEVATION		
	SCHEDULE OF SLAB, TYPICAL SLAB DETAILS		
S-5	ROOF FRAMING PLAN. SCHEDULE OF BEAM, TYPICAL BEAM DETAIL		
	TYPICAL CORBEL DETAIL, TYPICAL CONCRETE GUTTER DETAIL, VERANDA SLAB DETAIL		
S-6	TRUSS DETAIL, TRUSS CONNRCTION DETAIL		
	STAIR DETAILS		

Republic of the Philippines
Department of Public Works & Highways
OFFICE OF THE BUILDING OFFICIAL

District/City/Municipality

LAND USE & ZONING

LINE & GRADE

ARCHITECTURAL

STRUCTURAL

ELECTRICAL

MECAHANICAL

SANITARY

PLUMBING

ELECTRONICS

GEODETIC ENGINEER

ACO
CONSULTING ENGINEERS
4th FLOOR, 141 DELA ROSA
COR. SALCEDO STS., LEGASPI VILLAGE,
MAKATI CITY, PHILIPPINES
TEL : (632) 812-4935
FAX : (632) 813-5543
E-MAIL : acoconsulting@aco.com.ph

TITO MOISES S. ENCINAS

ARCHITECT

UAP-IAPOA NO. : 03087-023336-082608

REG. NO. 6842

TIN: 134-625-305

PTR. NO. 0009265

DATE: 01-12-2009

PLACE ISSUED: MAKATI CITY

CONSULTANT



MOHRI & P.A. ASSOCIATES, INC.
3RD FLOOR, #101 CACHO-GONZALEZ BLDG., AGUIRRE COR. TRAGIERRA STREET, LEGASPI VILLAGE MAKATI CITY, PHILIPPINES
TEL : 892-4609 / 892-4611 / 892-4614 FAX : 892-4605 E-MAIL : mpa@info.com.ph

PROJECT TITLE

**PROPOSED PHILIPPINE SCIENCE HIGH SCHOOL
ADMINISTRATION BUILDING**

LOCATION: BRGY. TAGONTONG, GOA, CAMARINES SUR

REVISIONS

REV NO.	DESCRIPTION	BY	DATE

DESIGN BY:

DRAWN BY:

SCALE:

CHECKED BY:

DATE:

PROJECT NO.:

OWNER



ELSIE G. FERRER
CHIEF DIRECTOR



SHEET CONTENT

PERSPECTIVE
VICINITY MAP
LOCATION MAP
TABLE OF CONTENTS

SHEET NO.

1
A