


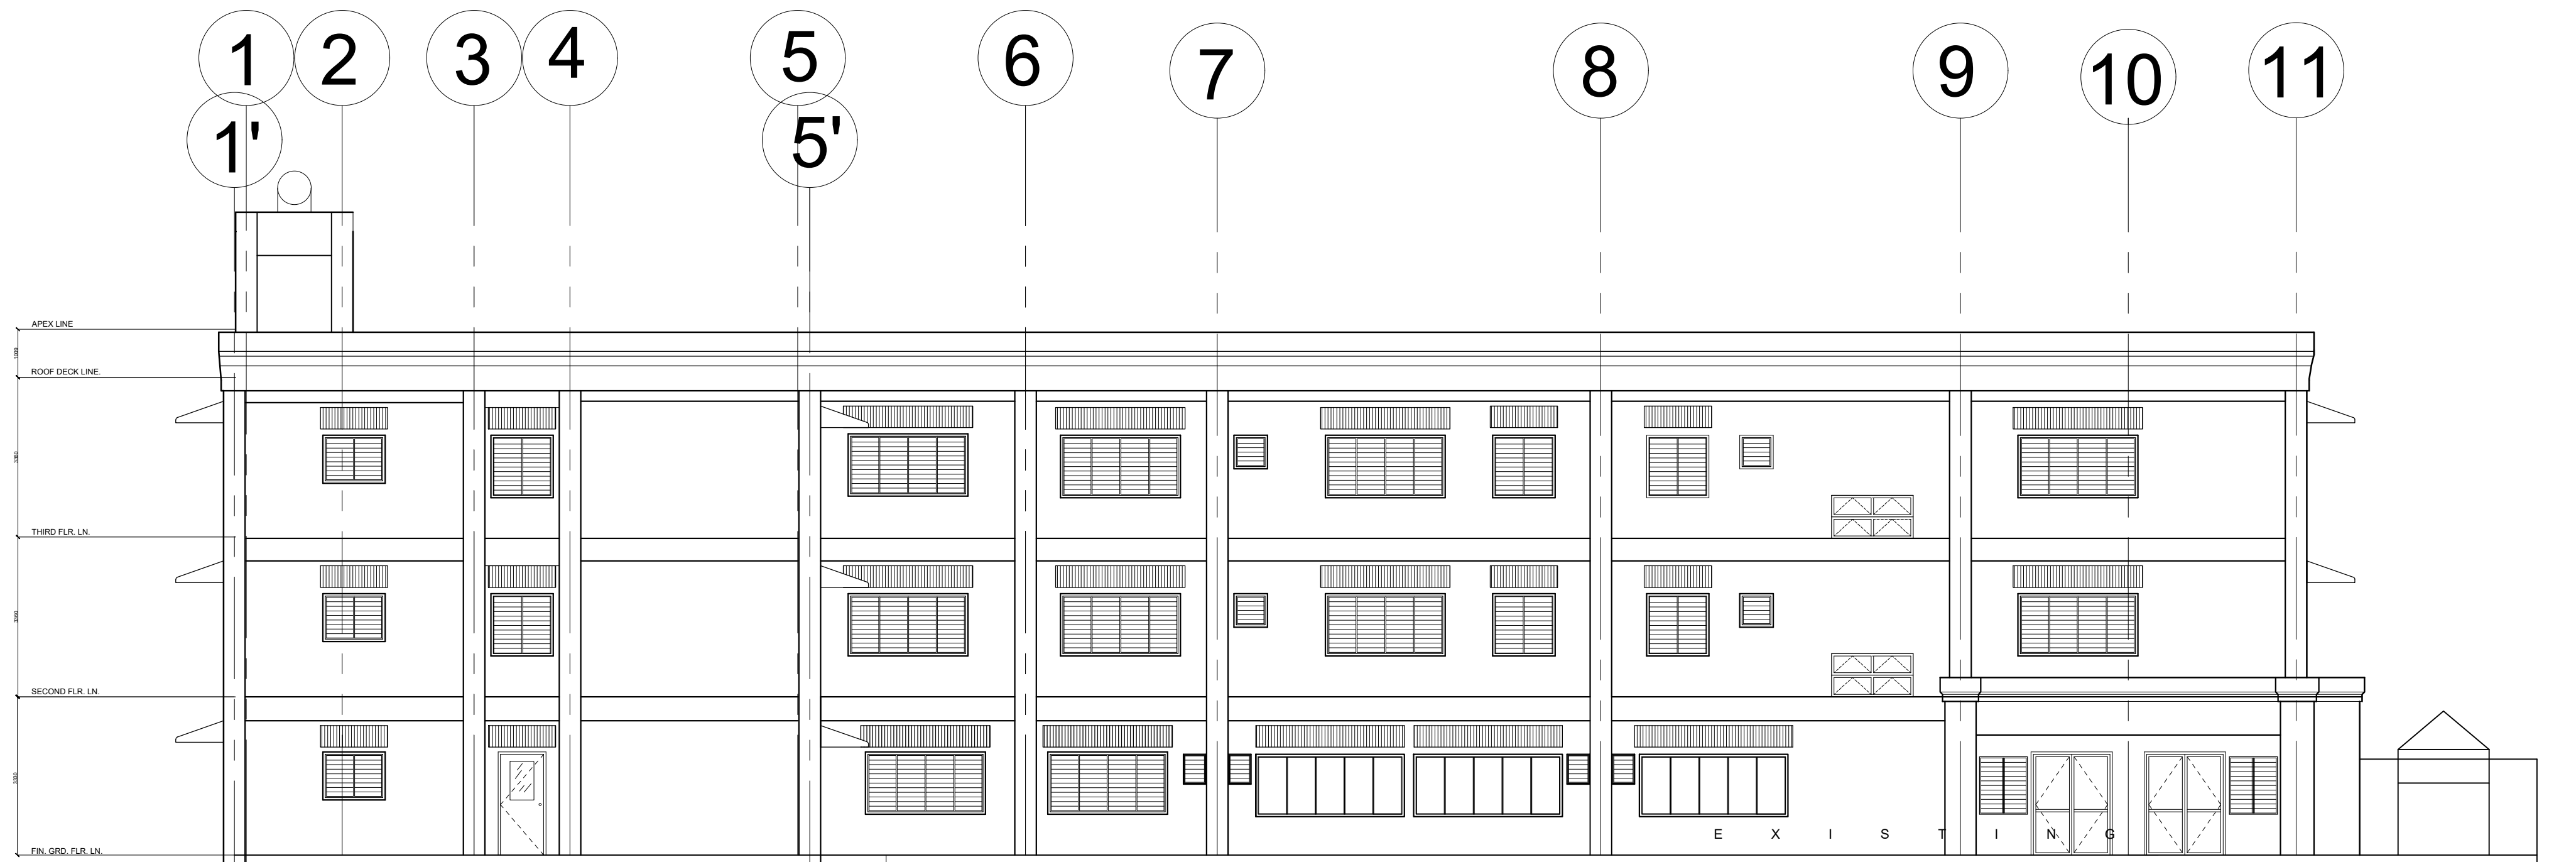

1  
A-6 RIGHT SIDE ELEVATION  
SCALE 1:100M



1  
A-6 LEFT SIDE ELEVATION  
SCALE 1:100M

		ARCHITECT		SUBMITTED BY:		PROJECT TITLE		SHEET CONTENTS		OWNER		RECOMMENDING APPROVAL:		APPROVED BY:		R.A. 9266 – THIS DRAWING IS AN INSTRUMENT OF SERVICE AND PROPERTY OF ASYANA CONSTRUCTION & CONSULTANCY. UNAUTHORIZED REPRODUCTION IN PART OR IN WHOLE IS PROHIBITED WITHOUT WRITTEN CONSENT.		SCALE		AS SHOWN		PROJECT I.D. NO.	
 <b>CONSTRUCTION &amp; CONSULTANCY</b>		ARCHITECT		ASYANA CONSTRUCTION CONSULTANCY		REHABILITATION OF SCHOOL BUILDINGS ACADEMIC BUILDING I,II AND DORMITORY BUILDING (BOY'S DORM)		(GROUND FLOOR) LIGHTING LAYOUT		 <b>PHILIPPINE SCIENCE HIGH SCHOOL BICOL REGION CAMPUS</b> DEPARTMENT OF SCIENCE AND TECHNOLOGY		JAY P. BASSIG FAD CHIEF		LORVI B. PAGOROGON, RPAE,MHWQ DIRECTOR III				CADD		JP/DANIELLE		202 - -	
																		CHECKED		FLB		SHEET NO.	
		Contact Number 0956-768-2678 ferbal_1@yahoo.com.ph		PTR NO. : DATE : PLACE :		REG. NO. : T.I.N. :		LOCATION: TAGONGTONG, GOA, CAMARINES SUR										DATE				<div><div>A</div><div>06</div></div>	